

NOTES

1. REFER TO DRAWING E-001 AND E-002 FOR ELECTRICAL SYMBOL LIST, ABBREVIATIONS AND GENERAL NOTES.
2. PROVIDE UNSWITCHED HOT LEG AHEAD OF LIGHTING CONTROLS FOR LIGHTING FIXTURES EQUIPPED WITH EMERGENCY BATTERY BACK-UP. REFER TO DETAILS SHEET FOR LIGHTING FIXTURE SCHEDULE.

THIS PLAN IS APPROVED ONLY FOR WORK INDICATED ON THE APPLICATION SPECIFICATION SHEET. ALL OTHER MATTERS SHOWN ARE NOT TO BE RELIED UPON, OR TO BE CONSIDERED AS EITHER BEING APPROVED OR IN ACCORDANCE WITH APPLICABLE CODES.


PROGRESS  
11-02-2011

DOB EMPLOYEE STAMPS AND SIGNATURES:

DOB BSCAN  
STICKER:

REVISION DATE REASON FOR ISSUE

KEY PLAN :

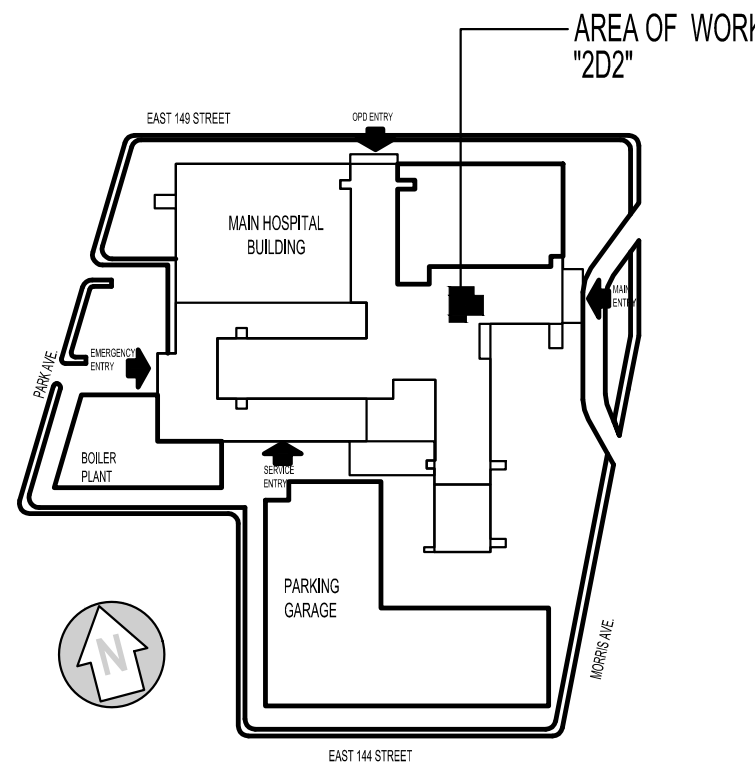

CLIENT:

**HHC** NEW YORK CITY  
HEALTH AND  
HOSPITALS  
CORPORATION

CLIENT:

 LINCOLN MEDICAL AND  
MENTAL HEALTH CENTER 

ARCHITECT:

**M J C L**  
Architects, PLLC  
1416 Avenue M, Brooklyn, NY 11230  
Tel.: (718) 339-3390 Fax: (718) 339-3642

ENVIRONMENTAL ENGINEERING CONSULTANT:

**Lilker Associates**  
Consulting Engineers, PC  
1001 Avenue of the Americas, New York, NY 10018  
Tel.: 212.695.1000 fax 212.695.1299 www.lilker.com

PROJECT:

NEW CLINIC RENOVATION AT SECOND FLOOR

DRAWING:

SECOND FLOOR  
LIGHTING PLAN

SCALE: 1/4" = 1'-0"

DRAWN BY: CP

CHECKED BY: GA

DATE: 09-06-2011

JOB #: 21115.00

DRAWING #:

E-101.00