

1 SECOND FLOOR PROPOSED POWER PLAN

SCALE: 1/4"=1'-0"

LEGEND

- NEW DUPLEX OUTLET
- NEW DEDICATED OUTLET
- NEW GF+ DUPLEX OUTLET
- NEW QUAD OUTLET
- NEW GF+ QUAD OUTLET
- NEW EMERGENCY DUPLEX OUTLET
- NEW COMBINATION TELEPHONE & DATA OUTLET
- NEW CABLE TV OUTLET
- NEW PHYSIOLOGIC MONITOR OUTLET
- NURSE CALL

GENERAL NOTES:

- COORDINATE EXACT LOCATIONS OF OUTLETS WITH TELEPHONE CONSOLE REQUIREMENTS.
- DATA JACKS, PHONE JACKS, AND CONVENIENCE OUTLETS TO BE INSTALLED AT 18" AFF. TYP UN ON ELEVATIONS.
- TYPICAL MOUNTING HEIGHT FOR SWITCHES SHALL BE 48" AFF UNO.
- ALL DEVICES SHALL BE MOUNTED AT CENTER OF WALL OR SOFT UNLESS OTHERWISE DIMENSIONED ON PLAN.
- DUPLEX OUTLET TO BE SURFACED MOUNTED. PROTECT WIRING & ELECTRICAL BOX AS REQUIRED.

NOTE:


1. THIS PLAN SHALL BE READ AND COORDINATED BY CONTRACTOR WITH ALL MEP DRAWINGS IN TERMS OF FINAL QUANTITY AND LOCATION OF OUTLETS & DEVICES. FINAL LOCATION OF PANELBOARDS SHALL BE VERIFIED ON SITE. ARCHITECT'S SHALL BE NOTIFIED OF CONFLICTS IN WRITING PRIOR TO COMMENCEMENT OF WORK.

DOB EMPLOYEE STAMPS AND SIGNATURES

DOB SSCAN STICKER

06-25-2012 ISSUED TO DOB  
11-03-2011 ISSUED FOR OWNER REVIEW  
REVISION DATE REASON FOR ISSUE

KEY PLAN :

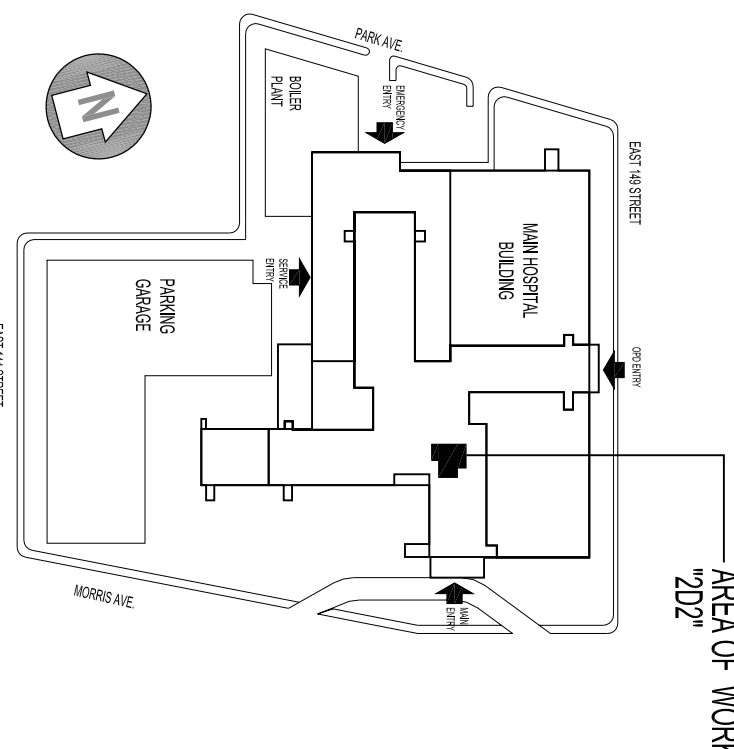

CLIENT

NEW YORK CITY  
HEALTH AND  
HOSPITALS  
CORPORATION

CLIENT

LINCOLN MEDICAL AND  
MENTAL HEALTH CENTER  
234 East 149th Street, Bronx, New York 10451

ARCHITECT:

M J C L  
Architects, PLLC  
1416 Avenue M, Brooklyn, NY 11230  
Tel.: (718) 338-5390 Fax: (718) 538-8642

ENVIRONMENTAL ENGINEERING CONSULTANT:

Lilker  
Lilker Associates  
Consulting Engineers, PC  
1001 Avenue of the Americas, New York, NY 10018  
Tel: 212.695.1000 Fax: 212.695.1299 www.lilker.com

PROJECT:

NEW CLINIC RENOVATION AT SECOND FLOOR  
234 East 149 Street Bronx, NY 10451

DRAWING:

SECOND FLOOR POWER PLAN

SCALE: 1/4"=1'-0"  
DRAWN BY: CAD  
CHECKED BY: VC  
DATE: 09-06-2011  
JOB #: 21115.00

DRAWING #:

AE-100.00

of 35