


Filename: F:\2680 - Lincoln Medical Cn. Specialty Clinic\DWG\SP-201.00_Sprinkler.dwg User: Luis Alonzo Prid Date: 6/27/2012 12:18 PM

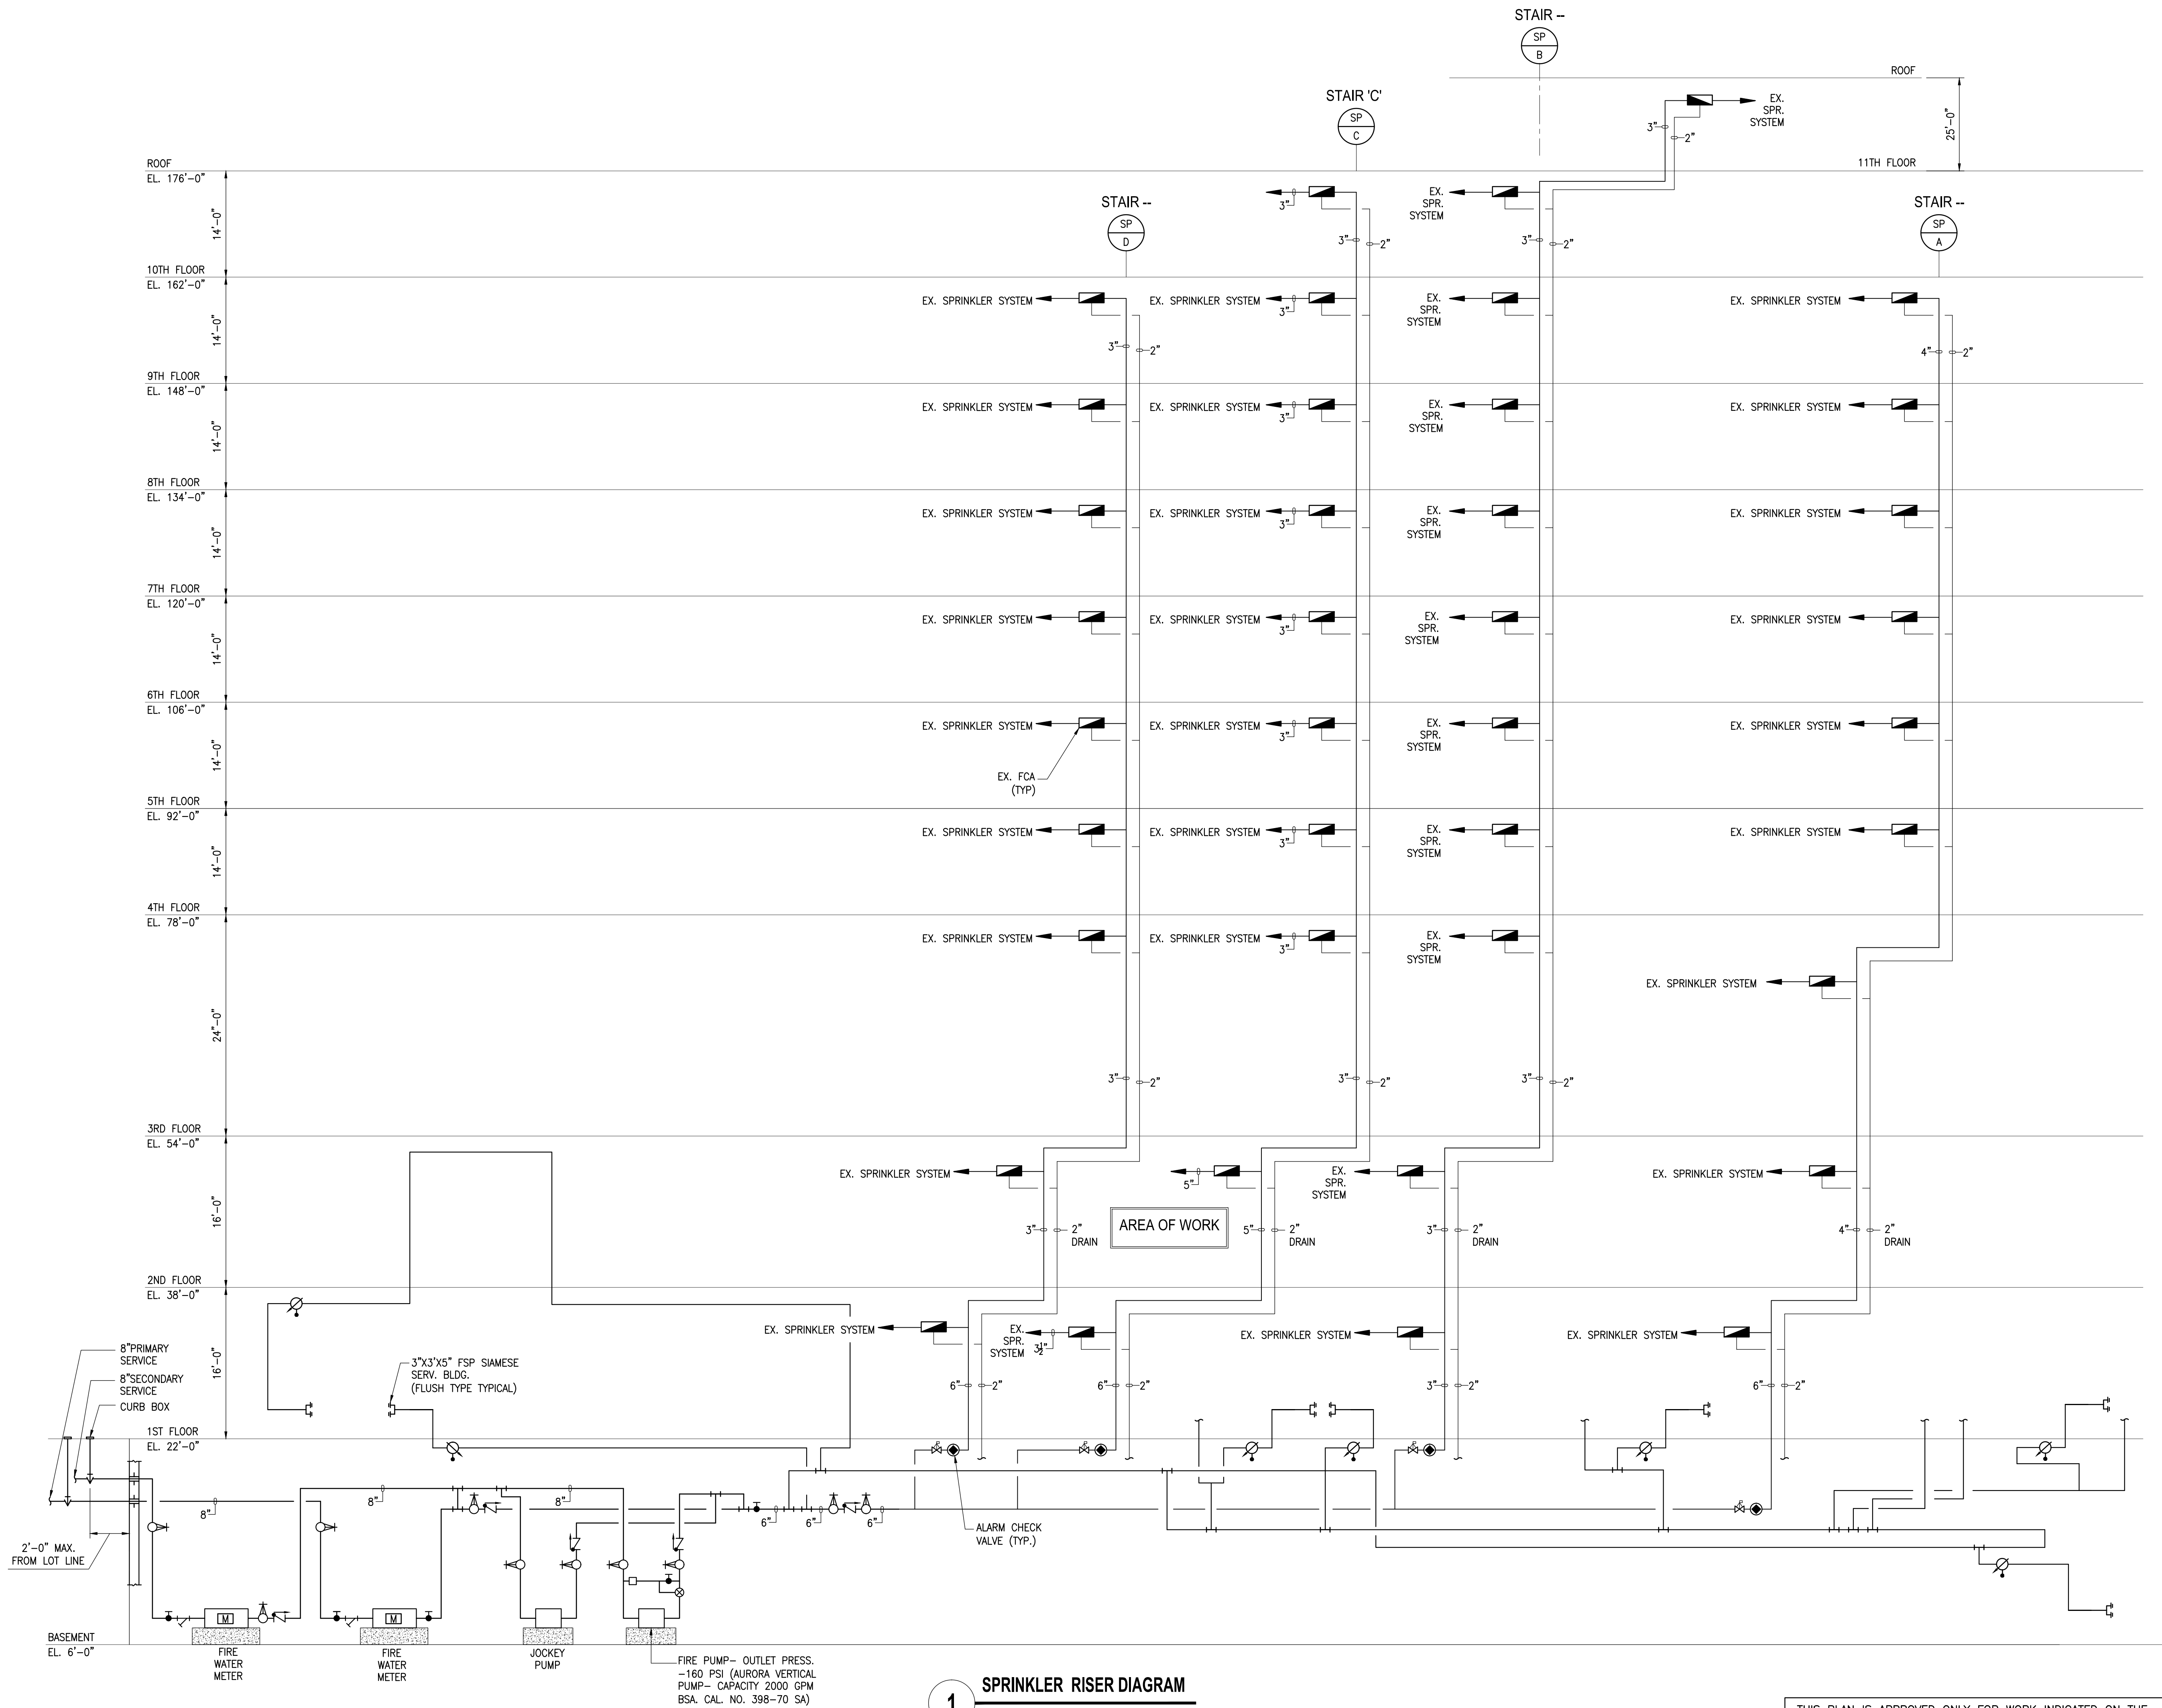

1 SPRINKLER RISER DIAGRAM
SCALE: NONE

THIS PLAN IS APPROVED ONLY FOR WORK INDICATED ON THE APPLICATION SPECIFICATION SHEET. ALL OTHER MATTERS SHOWN ARE NOT TO BE RELIED UPON, OR TO BE CONSIDERED AS EITHER BEING APPROVED OR IN ACCORDANCE WITH APPLICABLE CODES.

DOB EMPLOYEE STAMPS AND SIGNATURES:		DOB BSCAN STICKER:						
<table><tr><td>REVISION</td><td>DATE</td><td>REASON FOR ISSUE</td></tr><tr><td>06-25-2012</td><td>ISSUED TO DOB</td><td></td></tr></table>			REVISION	DATE	REASON FOR ISSUE	06-25-2012	ISSUED TO DOB	
REVISION	DATE	REASON FOR ISSUE						
06-25-2012	ISSUED TO DOB							
KEY PLAN :								
CLIENT:								
NEW YORK CITY HEALTH AND HOSPITALS CORPORATION								
CLIENT:								
LINCOLN MEDICAL AND MENTAL HEALTH CENTER 234 East 149th Street, Bronx, New York 10451								
ARCHITECT:								
M J C L Architects, PLLC 1416 Avenue M, Brooklyn, NY 11230 Tel.: (718) 339-3390 Fax: (718) 339-3642								
ENVIRONMENTAL ENGINEERING CONSULTANT:								
Lilker Associates Consulting Engineers, PC 1001 Avenue of the Americas, New York, NY 10018 tel. 212.695.1000 fax 212.695.1299 www.lilker.com								
PROJECT:								
NEW CLINIC RENOVATION AT SECOND FLOOR 234 East 149 Street Bronx, NY 10451								
DRAWING:								
SPRINKLER RISER DIAGRAM								
SCALE :	1/4"=1'-0"	DRAWING #:						
DRAWN BY :	-	SP-201.00						
CHECKED BY :	PF							
DATE :	09-06-2011							
JOB # :	21115.00	32 of 36						