



1 CELLAR FINISH PLAN
SCALE: 1/4" = 1'-0"

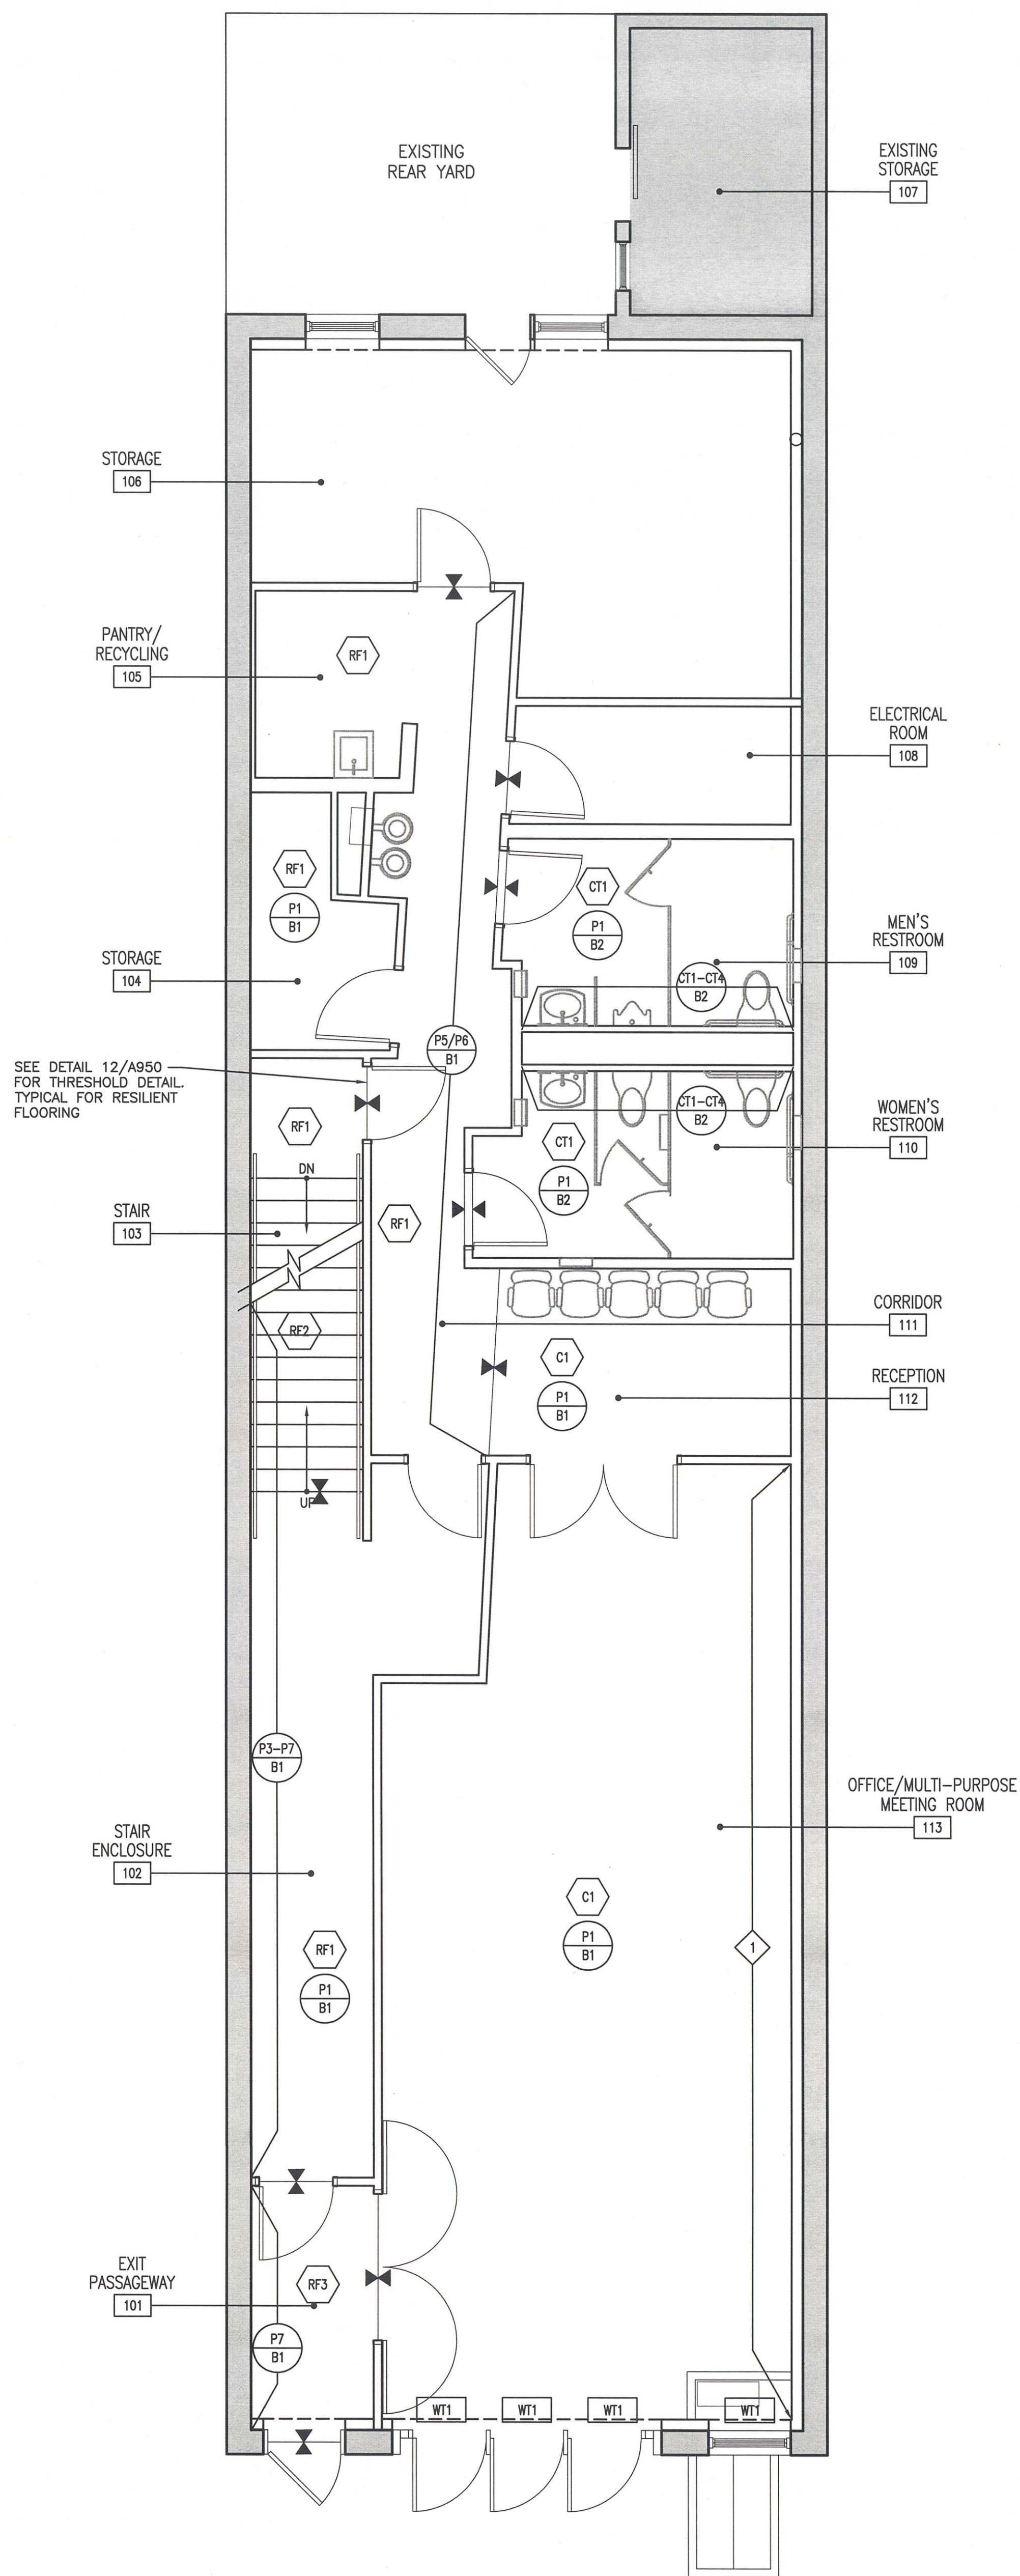

2 FIRST FLOOR FINISH PLAN
SCALE: 1/4" = 1'-0"

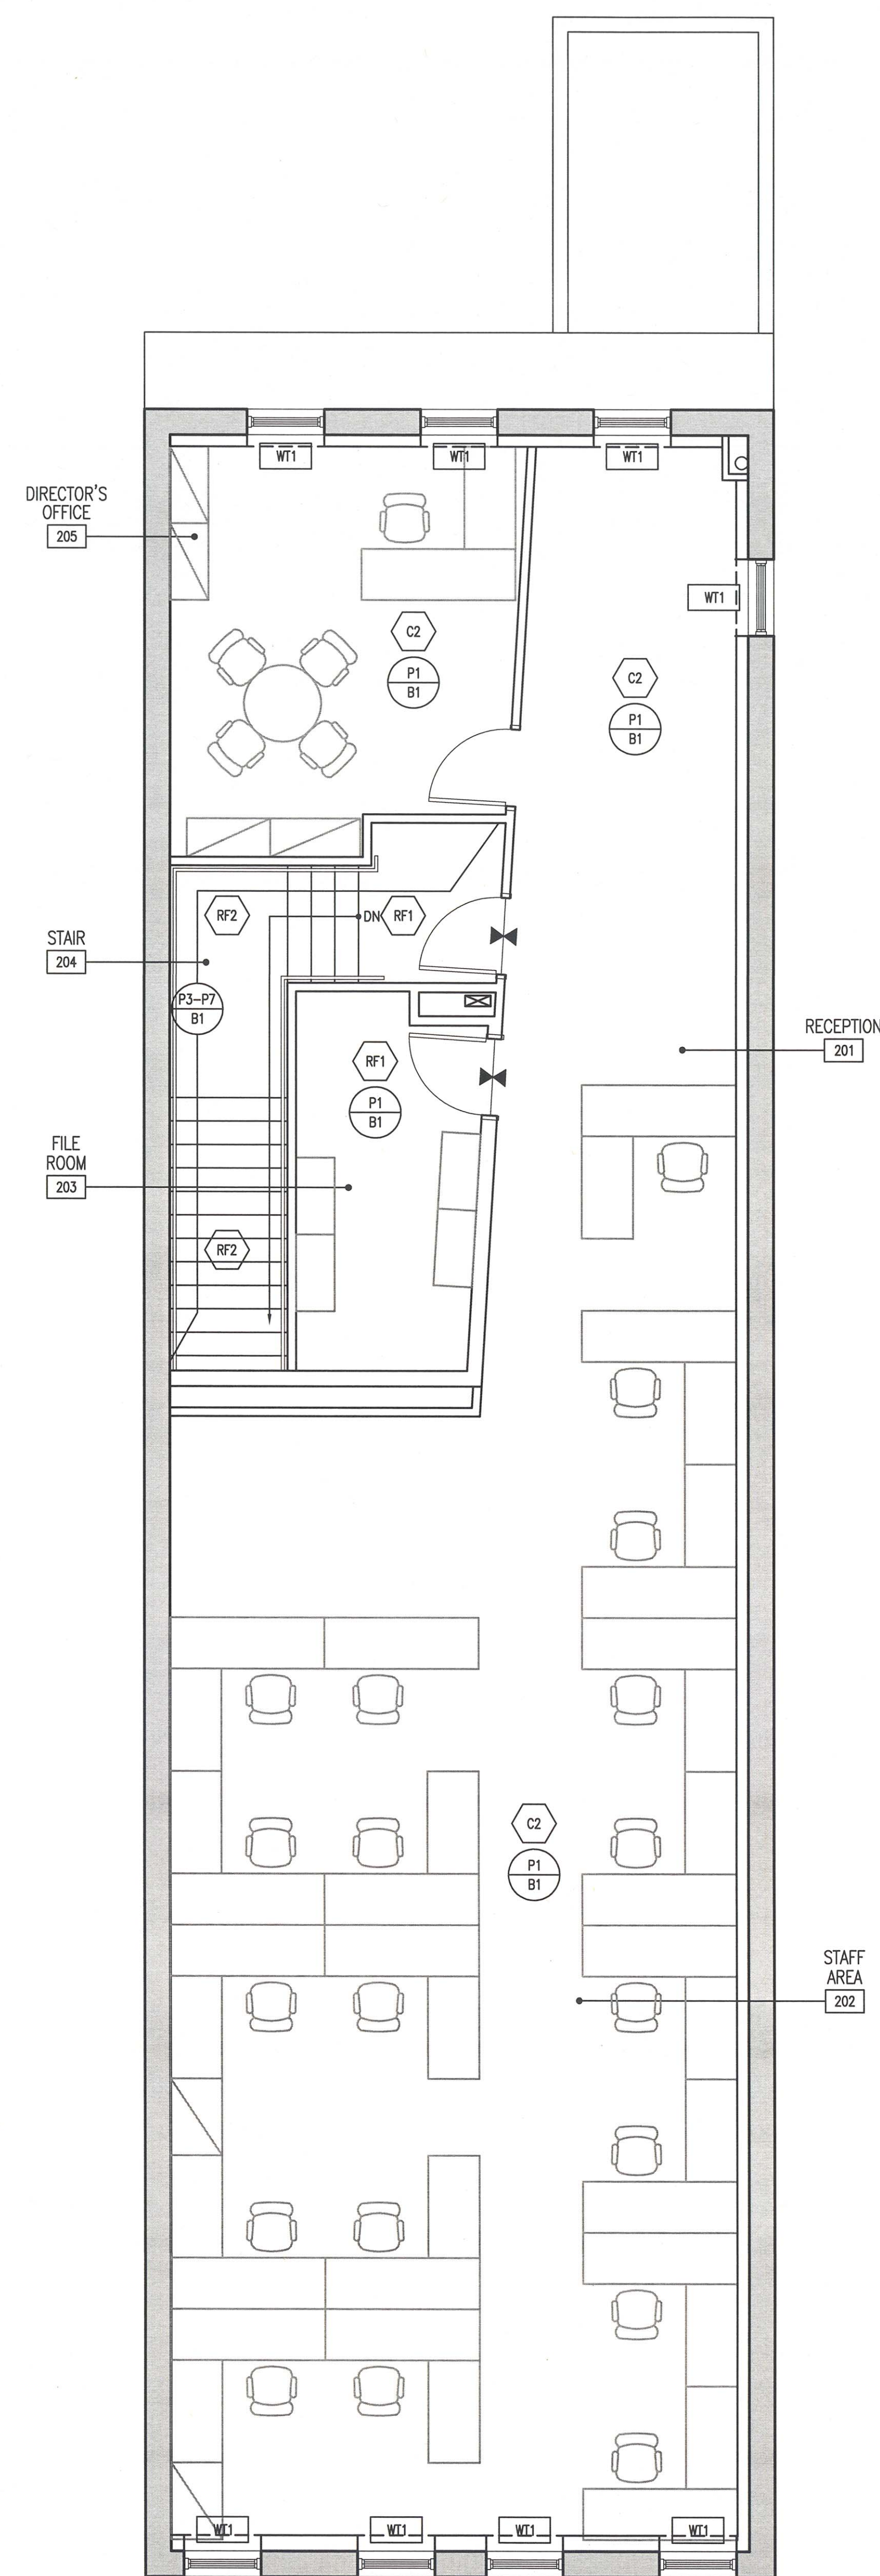

3 SECOND FLOOR PLAN
SCALE: 1/4" = 1'-0"

FINISH PLAN KEY NOTES

REFER TO SHEETS A-003 FOR ADDITIONAL NOTES & LEGENDS

- PATCH, REPAIR & MAKE FLUSH EXISTING WALL SURFACES; PREPARE TO RECEIVE NEW WALL & BASE FINISHES

FINISH LEGEND

- REFER TO SHEET A-920 FOR TYPE FLOOR FINISH MATERIAL BREAK W/TRANSITION STRIP
- PATTERN INDICATES MILLWORK ITEM.
- WALL FINISH SPECIFICATION (ABOVE)
- BASE FINISH SPECIFICATION (BELOW)
- FLOOR FINISH
- MILLWORK FINISH
- WINDOW TREATMENT

NOTE: SEE A006 FOR FINISH SPECIFICATIONS

Project
BROOKLYN
PHILHARMONIC
MUSIC CENTER
299 DeGraw Street, Brooklyn, NY 11231

Prepared for
Brooklyn Philharmonic
55 Washington Street, Suite 656
Brooklyn, NY 11201

Contract No: 79.07250.09



HOK
1065 Avenue of the Americas
New York, NY 10018 USA
T +1 212 741 1200 F +1 212 633 1163

All reproduction & intellectual property rights reserved © 2012




NYC Department of Design + Construction
30-30 Thompson Avenue, #5-076
Long Island City, NY 11101

Old Structures
Structural Engineers
111 Broadway, 14th Floor
New York, NY 10006

M-E Engineers
MEP Engineers
28 West 38th Street, 5th Floor
New York, NY 10018


Syska Hennessy Group
Lighting Consultant
11 West 42 Street
New York, NY 10036

Key Plan

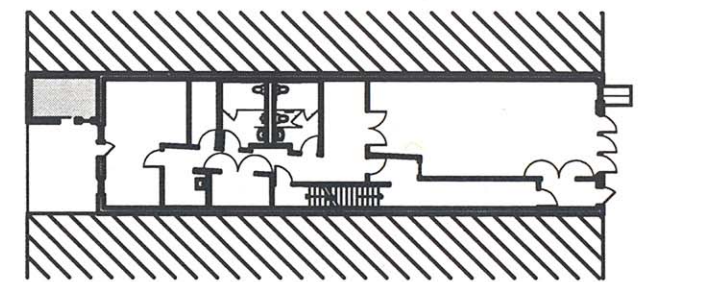

BLOCK: 414
LOT: 61

Professional Seals

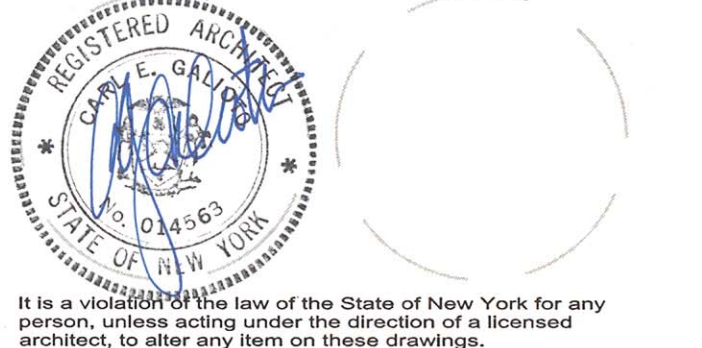

It is a violation of the law of the State of New York for any person, unless acting under the direction of a licensed architect, to alter any item on these drawings.

No. Issue Description MM-DD-YYYY

01 ISSUED FOR BIDDING 06-14-2012

02 ISSUED FOR BID 07-20-2012