


1 ENLARGED PLAN: TOILET 217
SCALE: 3/8"=1'-0"

2 ENLARGED PLAN: PATIENT TOILET 220
SCALE: 3/8"=1'-0"

3 ENLARGED PLAN: STAFF TOILET 221
SCALE: 3/8"=1'-0"

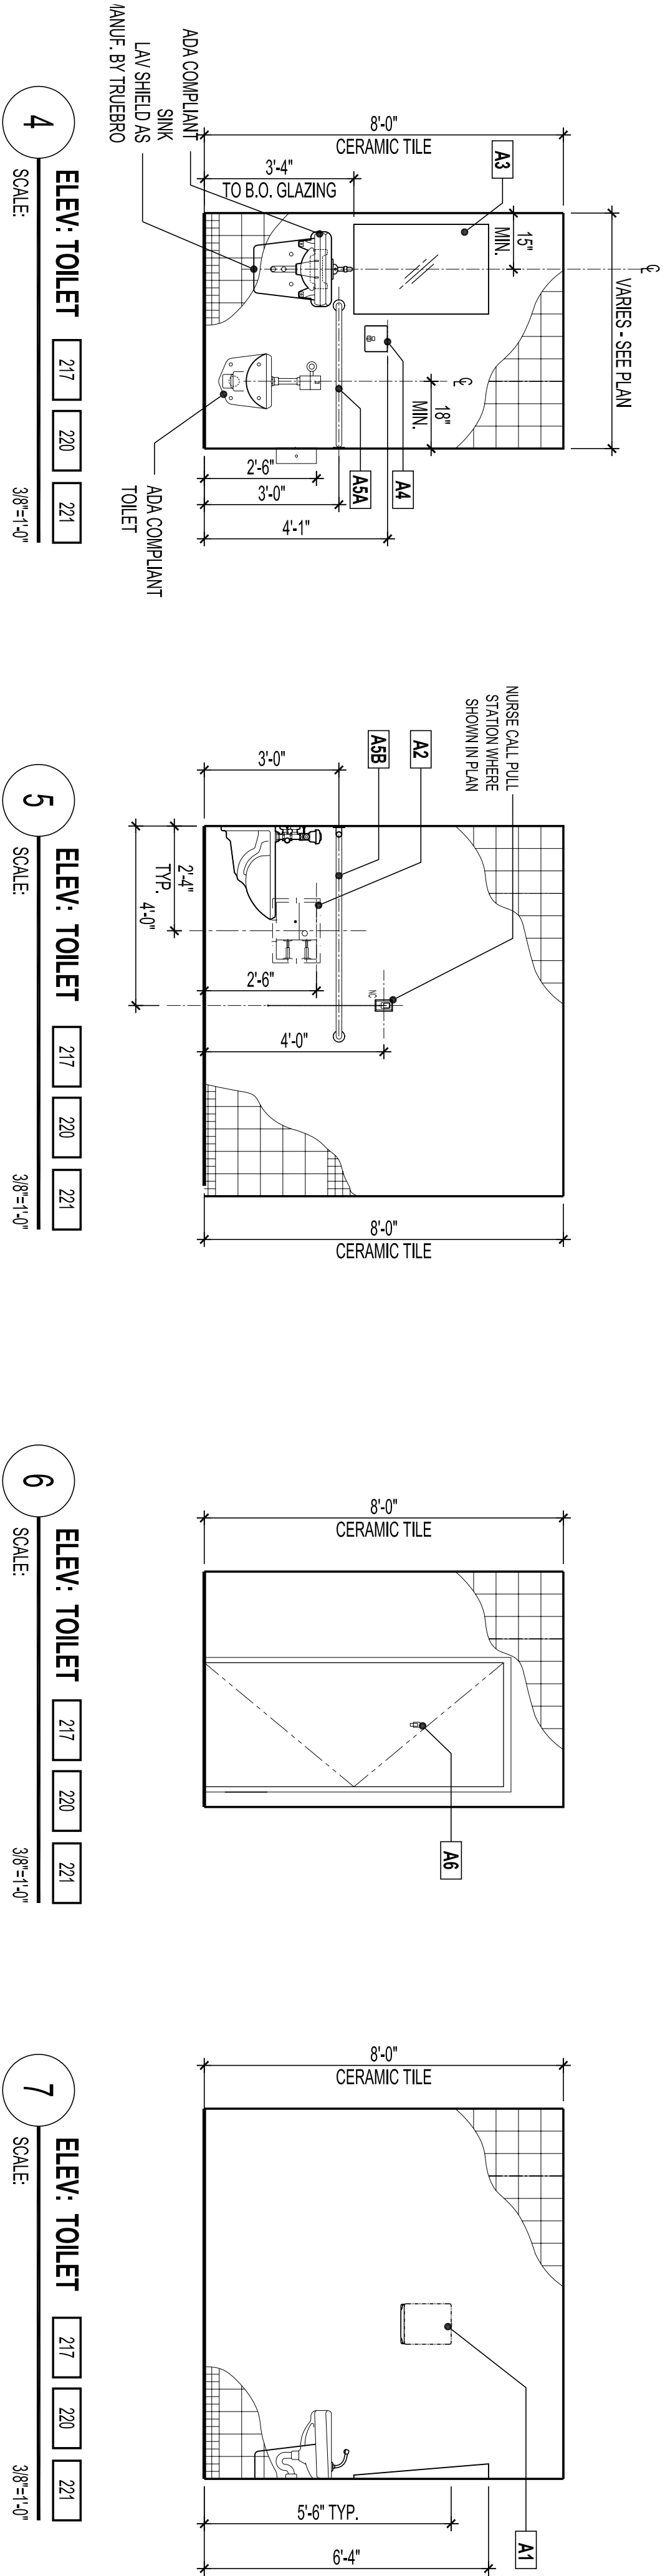

ACCESSORIES SCHEDULE

CODE	TYPE/ FUNCTION	MANUFACTURER	MODEL NUMBER
A1	SURFACE-MOUNTED PAPER TOWEL DISPENSER, OFC1	BOBRICK	B-4282
A2	RECESSED SANITARY WASTE DISPOSAL AND TOILET TISSUE DISPENSER, OFC1	BOBRICK	B-3084
A3	TILT MIRROR WITH STAINLESS STEEL ANGLE FRAME	BOBRICK	B-2804-08
A4	SURFACE-MOUNTED SOAP DISPENSER, OFC1	BOBRICK	B-4112
A5	1 1/4" Ø STAINLESS STEEL GRAB BARS WITH SWAP FLANGE	BOBRICK	B-4337
A5A	1 1/4" Ø STAINLESS STEEL GRAB BARS WITH SWAP FLANGE	BOBRICK	B-5068-39 X-35
A5B	1 1/4" Ø STAINLESS STEEL GRAB BARS WITH SWAP FLANGE	BOBRICK	B-5068-39 X-42
A6	COAT HOOK	BOBRICK	B-5452
A7	STAINLESS GLOVE BOX HOLDER, N/C	TO BE SELECTED, PROVIDED, AND INSTALLED BY OWNER	
A8	SHARPES DISPENSER	TO BE SELECTED, PROVIDED, AND INSTALLED BY OWNER	
A9	HAND SANITIZER	TO BE SELECTED, PROVIDED, AND INSTALLED BY OWNER	

NOTES:

- ALL ACCESSORIES NOTED AS N.I.C. ARE TO BE PROVIDED AND INSTALLED BY OWNER.
- CONTRACTOR TO PROVIDE TYPICAL PARTITION METAL REINFORCEMENT AS SHOWN ON DWG. 51A-300.00 FOR ALL WALL-MOUNTED ACCESSORIES IN ACCESSORIES SCHEDULE.
- FOR PLUMBING FIXTURES AND FITTINGS SEE PLUMBING DRAWINGS.
- FOR CERAMIC TILE PATTERN, REFER TO SHEET A-131.00.

DOB EMPLOYEE STAMPS AND SIGNATURES

DOB SSCAN
STICKER

REVISION

DATE

REASON FOR ISSUE

ISSUED TO DOB

ISSUED FOR OWNER REVIEW

REASON FOR ISSUE

KEY PLAN :

AREA OF WORK

"202"

CLIENT

NEW YORK CITY
HEALTH AND
HOSPITALS
CORPORATION

CLIENT

LINCOLN MEDICAL AND
MENTAL HEALTH CENTER

ARCHITECT:

M J C L
Architects, PLLC
1416 Avenue M, Brooklyn, NY 11230
Tel.: (718) 338-5390 Fax: (718) 538-8642

ENVIRONMENTAL ENGINEERING CONSULTANT:

Lilker Associates
Consulting Engineers, PC
1001 Avenue of the Americas, New York, NY 10018
Tel: 212.695.1000 Fax 212.695.1299 www.lilker.com

PROJECT:

NEW CLINIC RENOVATION AT SECOND FLOOR
234 East 149 Street Bronx, NY 10451

BROWNING:

ENLARGED TOILET PLANS AND ELEVATIONS

SCALE :

AS SHOWN

DRAWING# :

A-200.00

DRAWN BY :

CAD

CHECKED BY :

VC

DATE :

09-06-2011

JOB # :

21115.00

13 of 36